


DATE:19 - 06 - 2025

DRG NO:PA/PD-04/2025

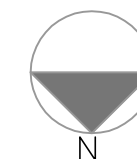

NOTES AND REVISIONS :

PROJECT:


PROPOSED ELECTRICAL LAYOUT
FOR MS. PARUL AJMERA'S
RESIDENCE AT DIVINE
APARTMENTS, JUHU, MUMBAI

D:\Users\Admin\Desktop\SKA new logo.jpg

601, ESPERANZA,
198 LINKING ROAD, BANDRA WEST,
MUMBAI 400050
T : 022 26424790

OFF NO: 8,16,17, 38-WEST,
ROAD NO.6,
SION(W),
MUMBAI-400 022

EMAIL: designers@spaceforte.com.
WEBSITE: www.skaarchitectsindia.com

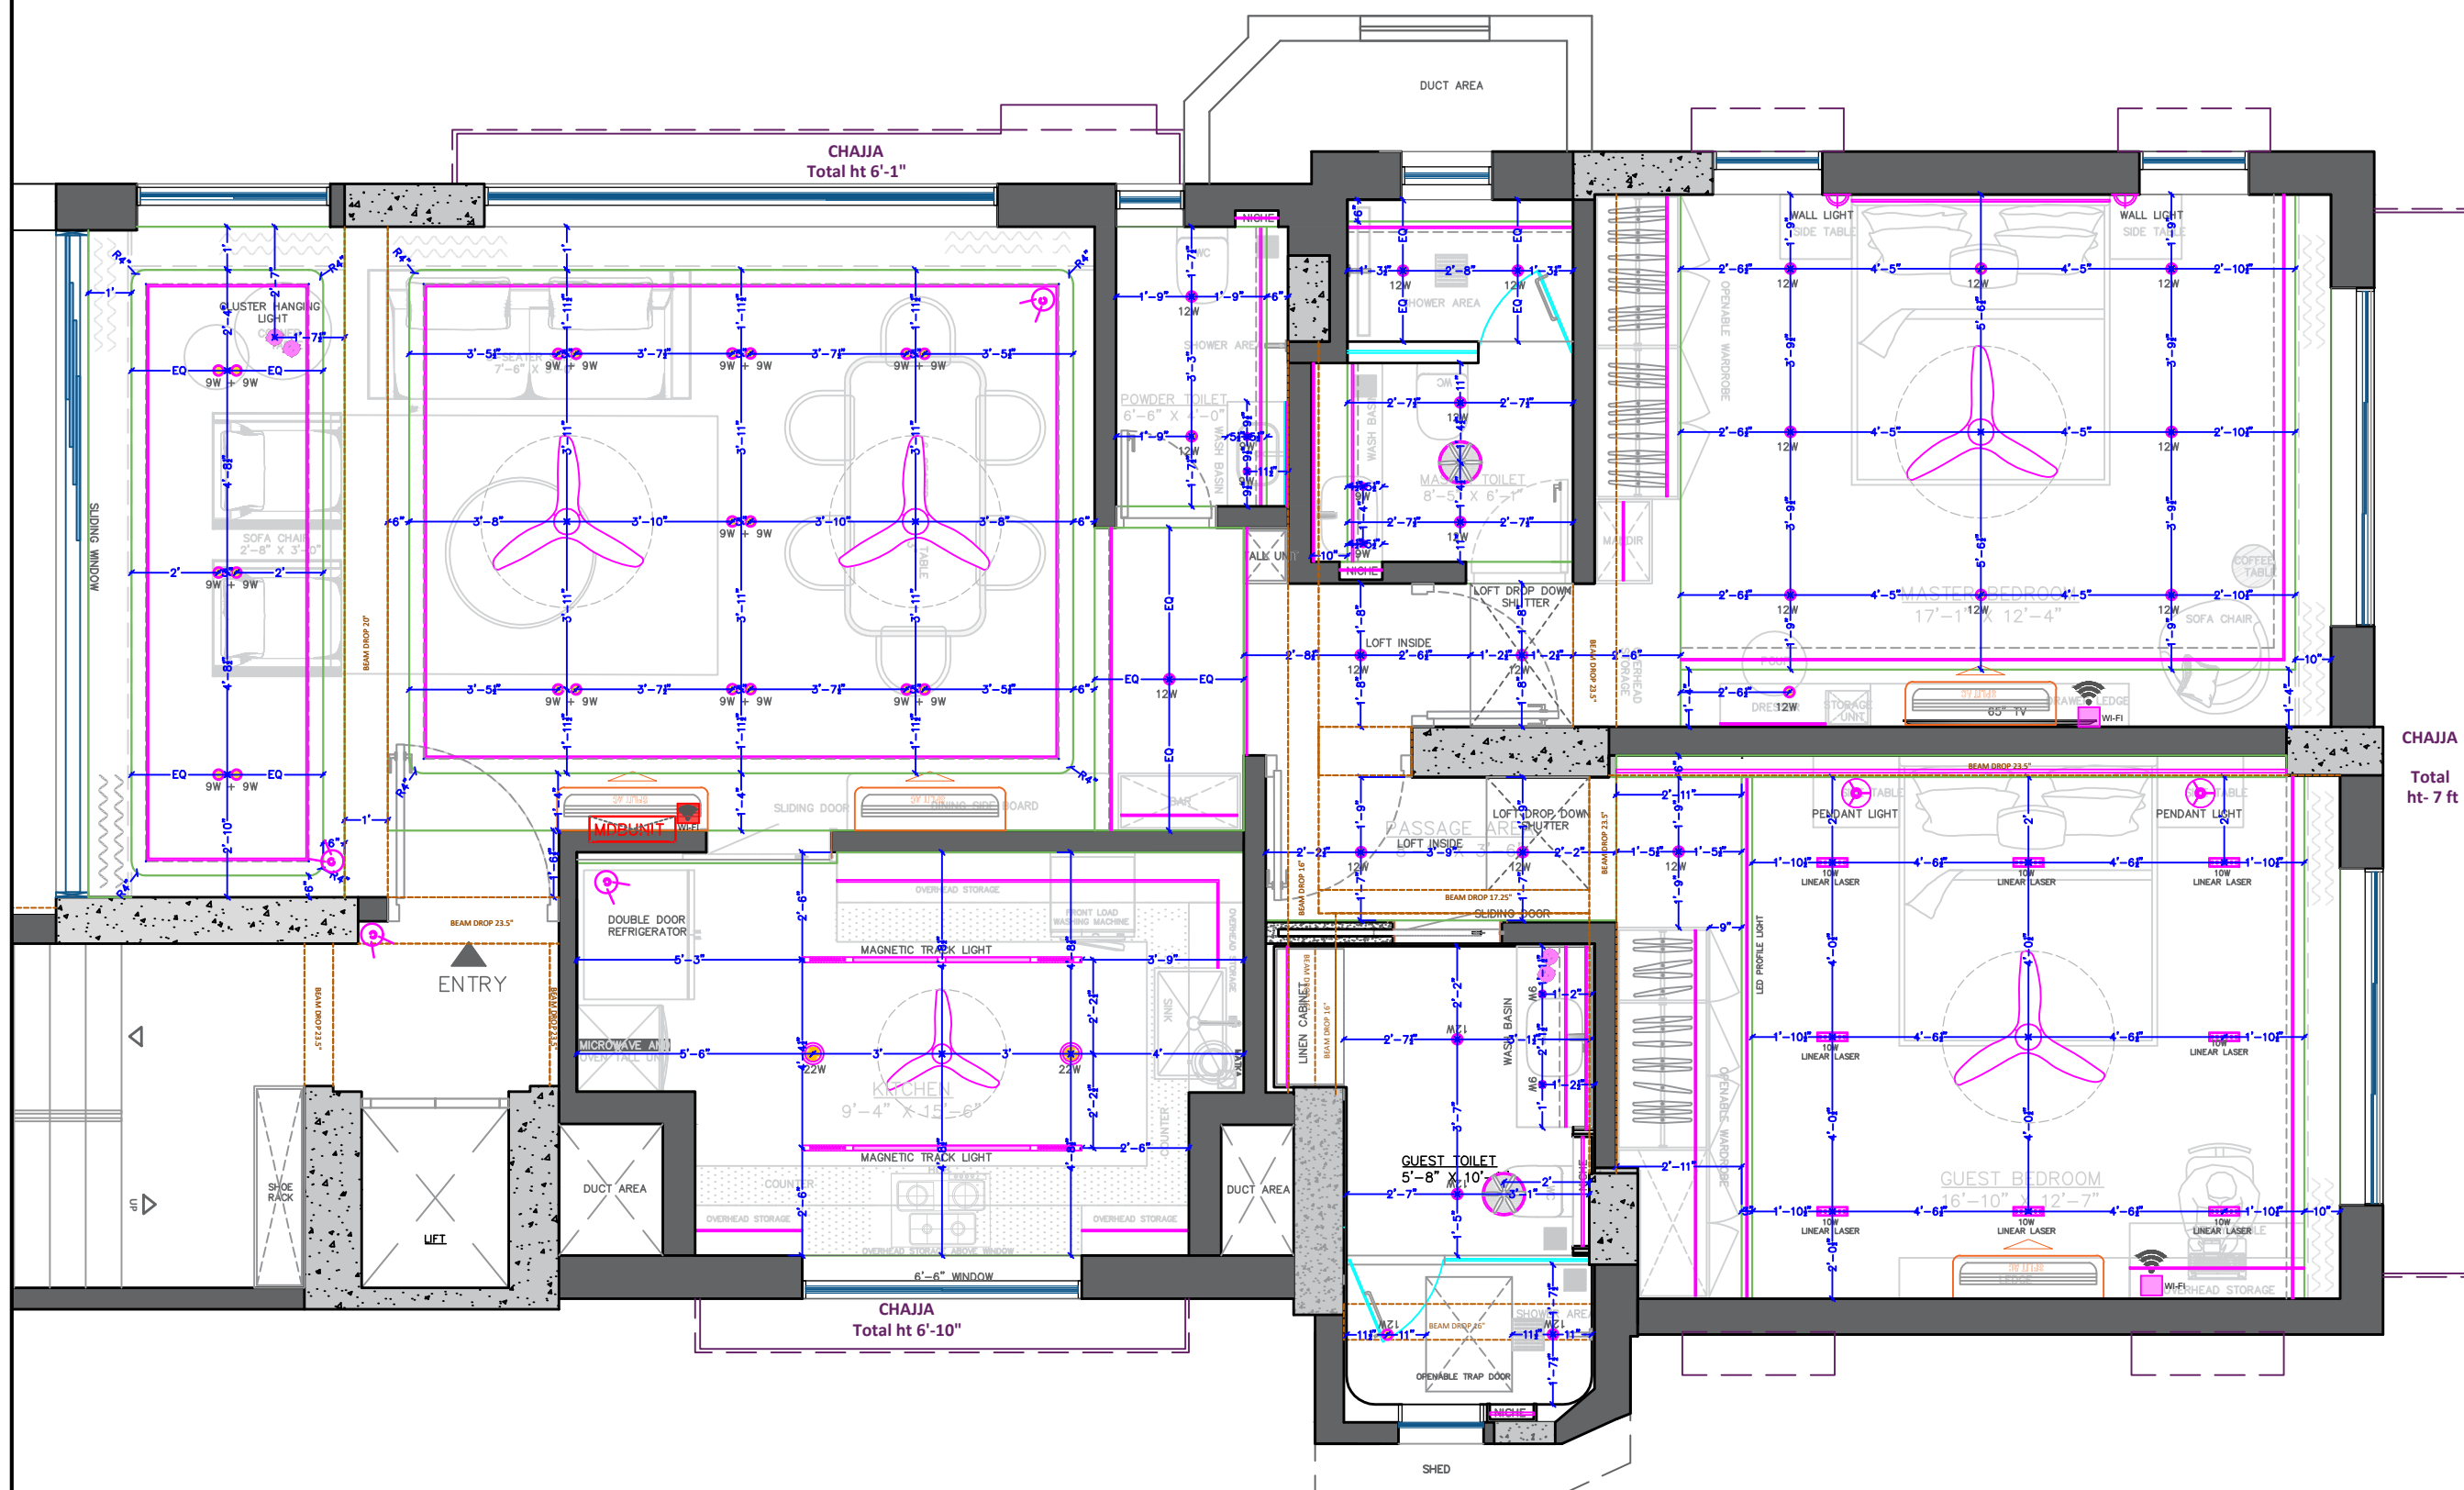

ELECTRICAL LAYOUT PLAN WITH
MEASUREMENT